


REGIONAL DISTRICT OF FRASER-FORT GEORGE

BEAR LAKE WATER SYSTEM REPLACEMENT SURGE TANK REQUEST FOR PROPOSALS (RFP)



DRAWING INDEX

Dwg No.	Rev.	Description
00	1	COVER - LOCATION MAP - INDEX TO DRAWINGS
01	1	SITE PLAN

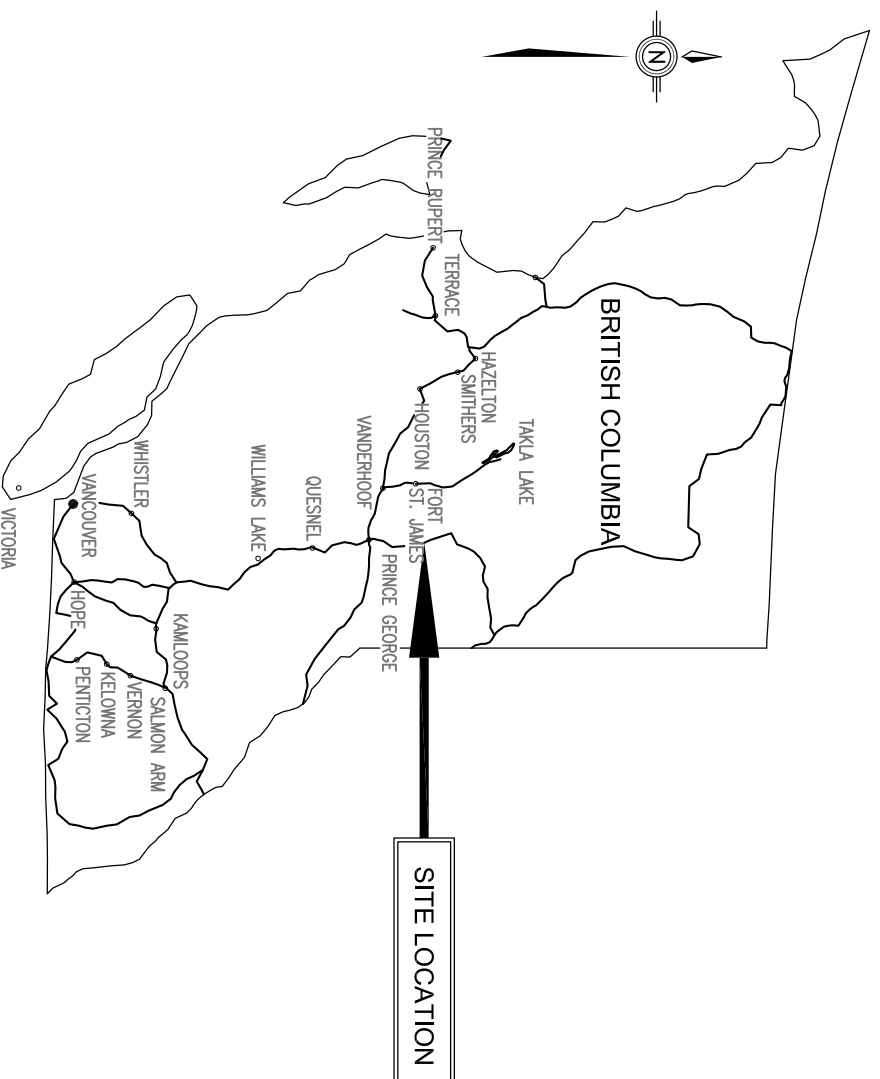


LOCATION MAP

 OPUS DAYTONKNIGHT	
Prince George Office 201 - 1110 8TH AVENUE Prince George, BC +1 250 5620038 V2L 3M6 CANADA	
PROJECT No.:	D-47111.02
DATE:	SEPTEMBER 2013
PROJECT MANAGER:	DDK
DESIGNER:	DDK
DRAFTSPERSON(S):	DDK

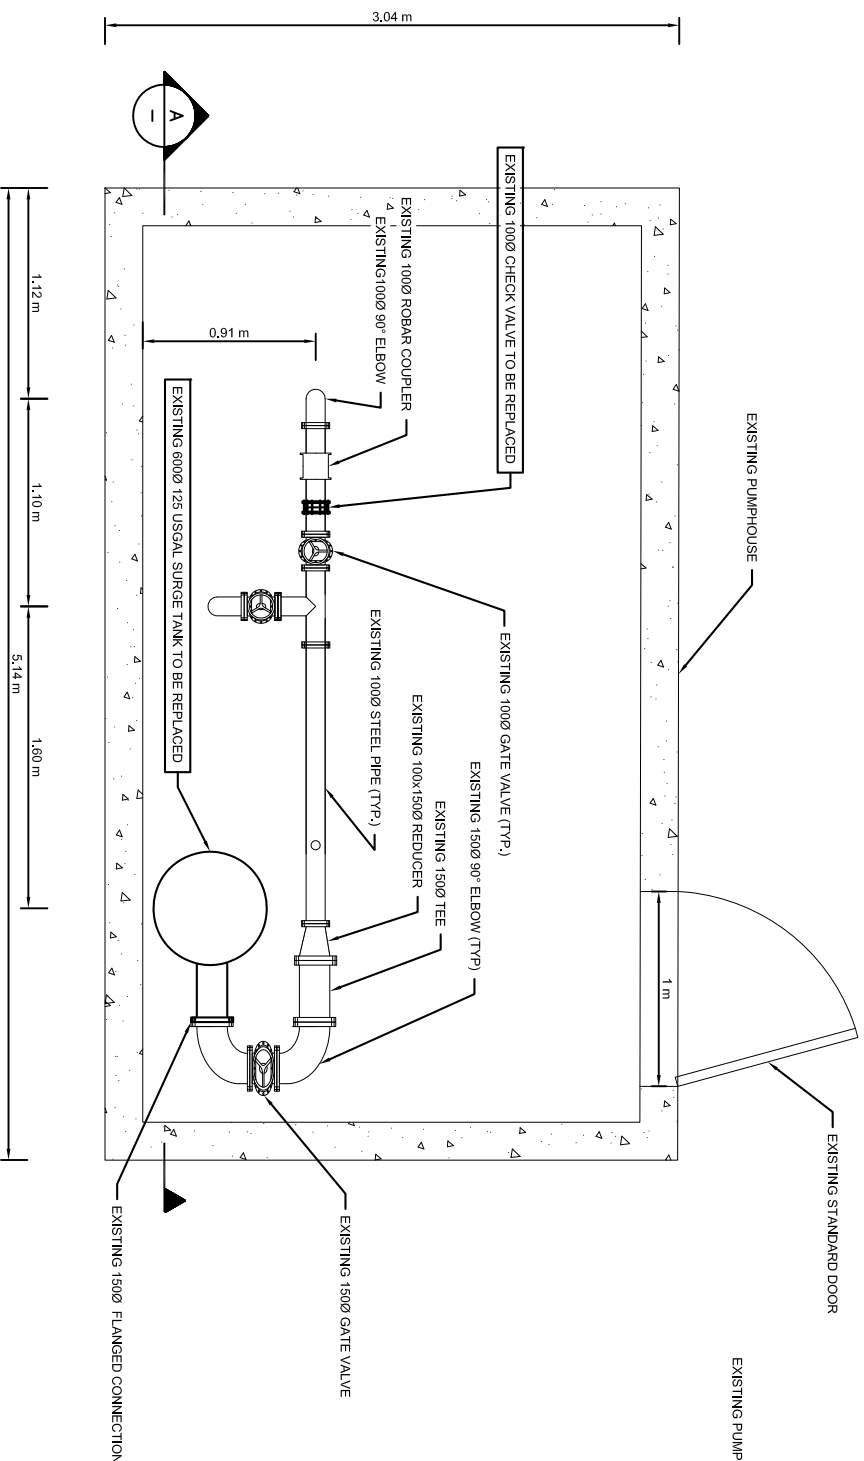 

PLAN

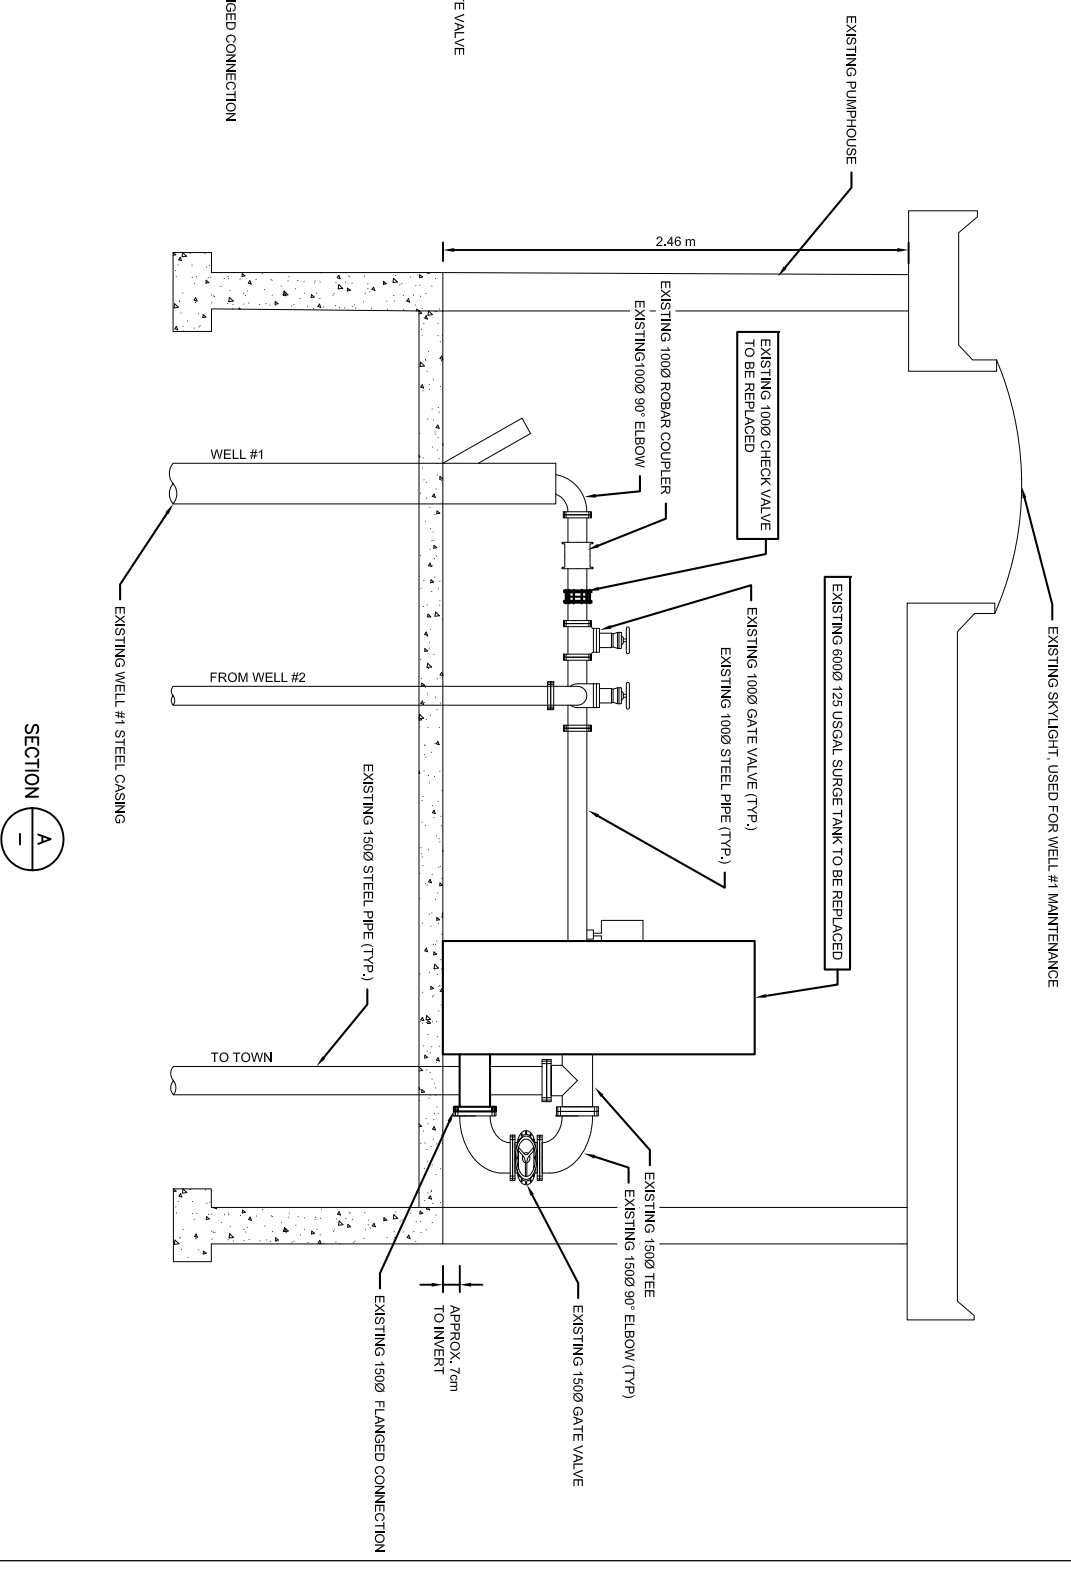

SECTION A-A

NOTE:
 THESE DRAWINGS ARE BASED OFF THE RECORD DRAWING FROM 1977, AND SHOULD BE CONSIDERED APPROXIMATE. PROPONENTS SHALL NOT RELY ON THESE DRAWINGS. DIMENSIONS SHALL BE DEFINED IN SHOP DRAWINGS FOR REVIEW, AND CONFIRMED WITH FIELD MEASUREMENTS, PRIOR TO FABRICATION.

ISSUED FOR RFP



Revision	Description	Approved	Revision Date
1	ISSUED FOR RFP	DDK	25.09.13

<p>OPUS DAYTONKNIGHT Prince George Office 201 - 1110 6TH AVENUE V2L 3M6 CANADA</p>		<p>Project: REGIONAL DISTRICT OF FRASER-FORT GEORGE BEAR LAKE WATER SYSTEM REPLACEMENT SURGE TANK</p>	
Drawn: DDK	Designed: DDK	Approved: DDK	Revision Date:
Project No: D-471102	Scale: 1:20	Sheet No: 01	Revision: 1